


P&R-Sharp Road Park
 Caroline County, MD
BASEBALL - 30/20 FC
25-2258-BB-SB-AGI

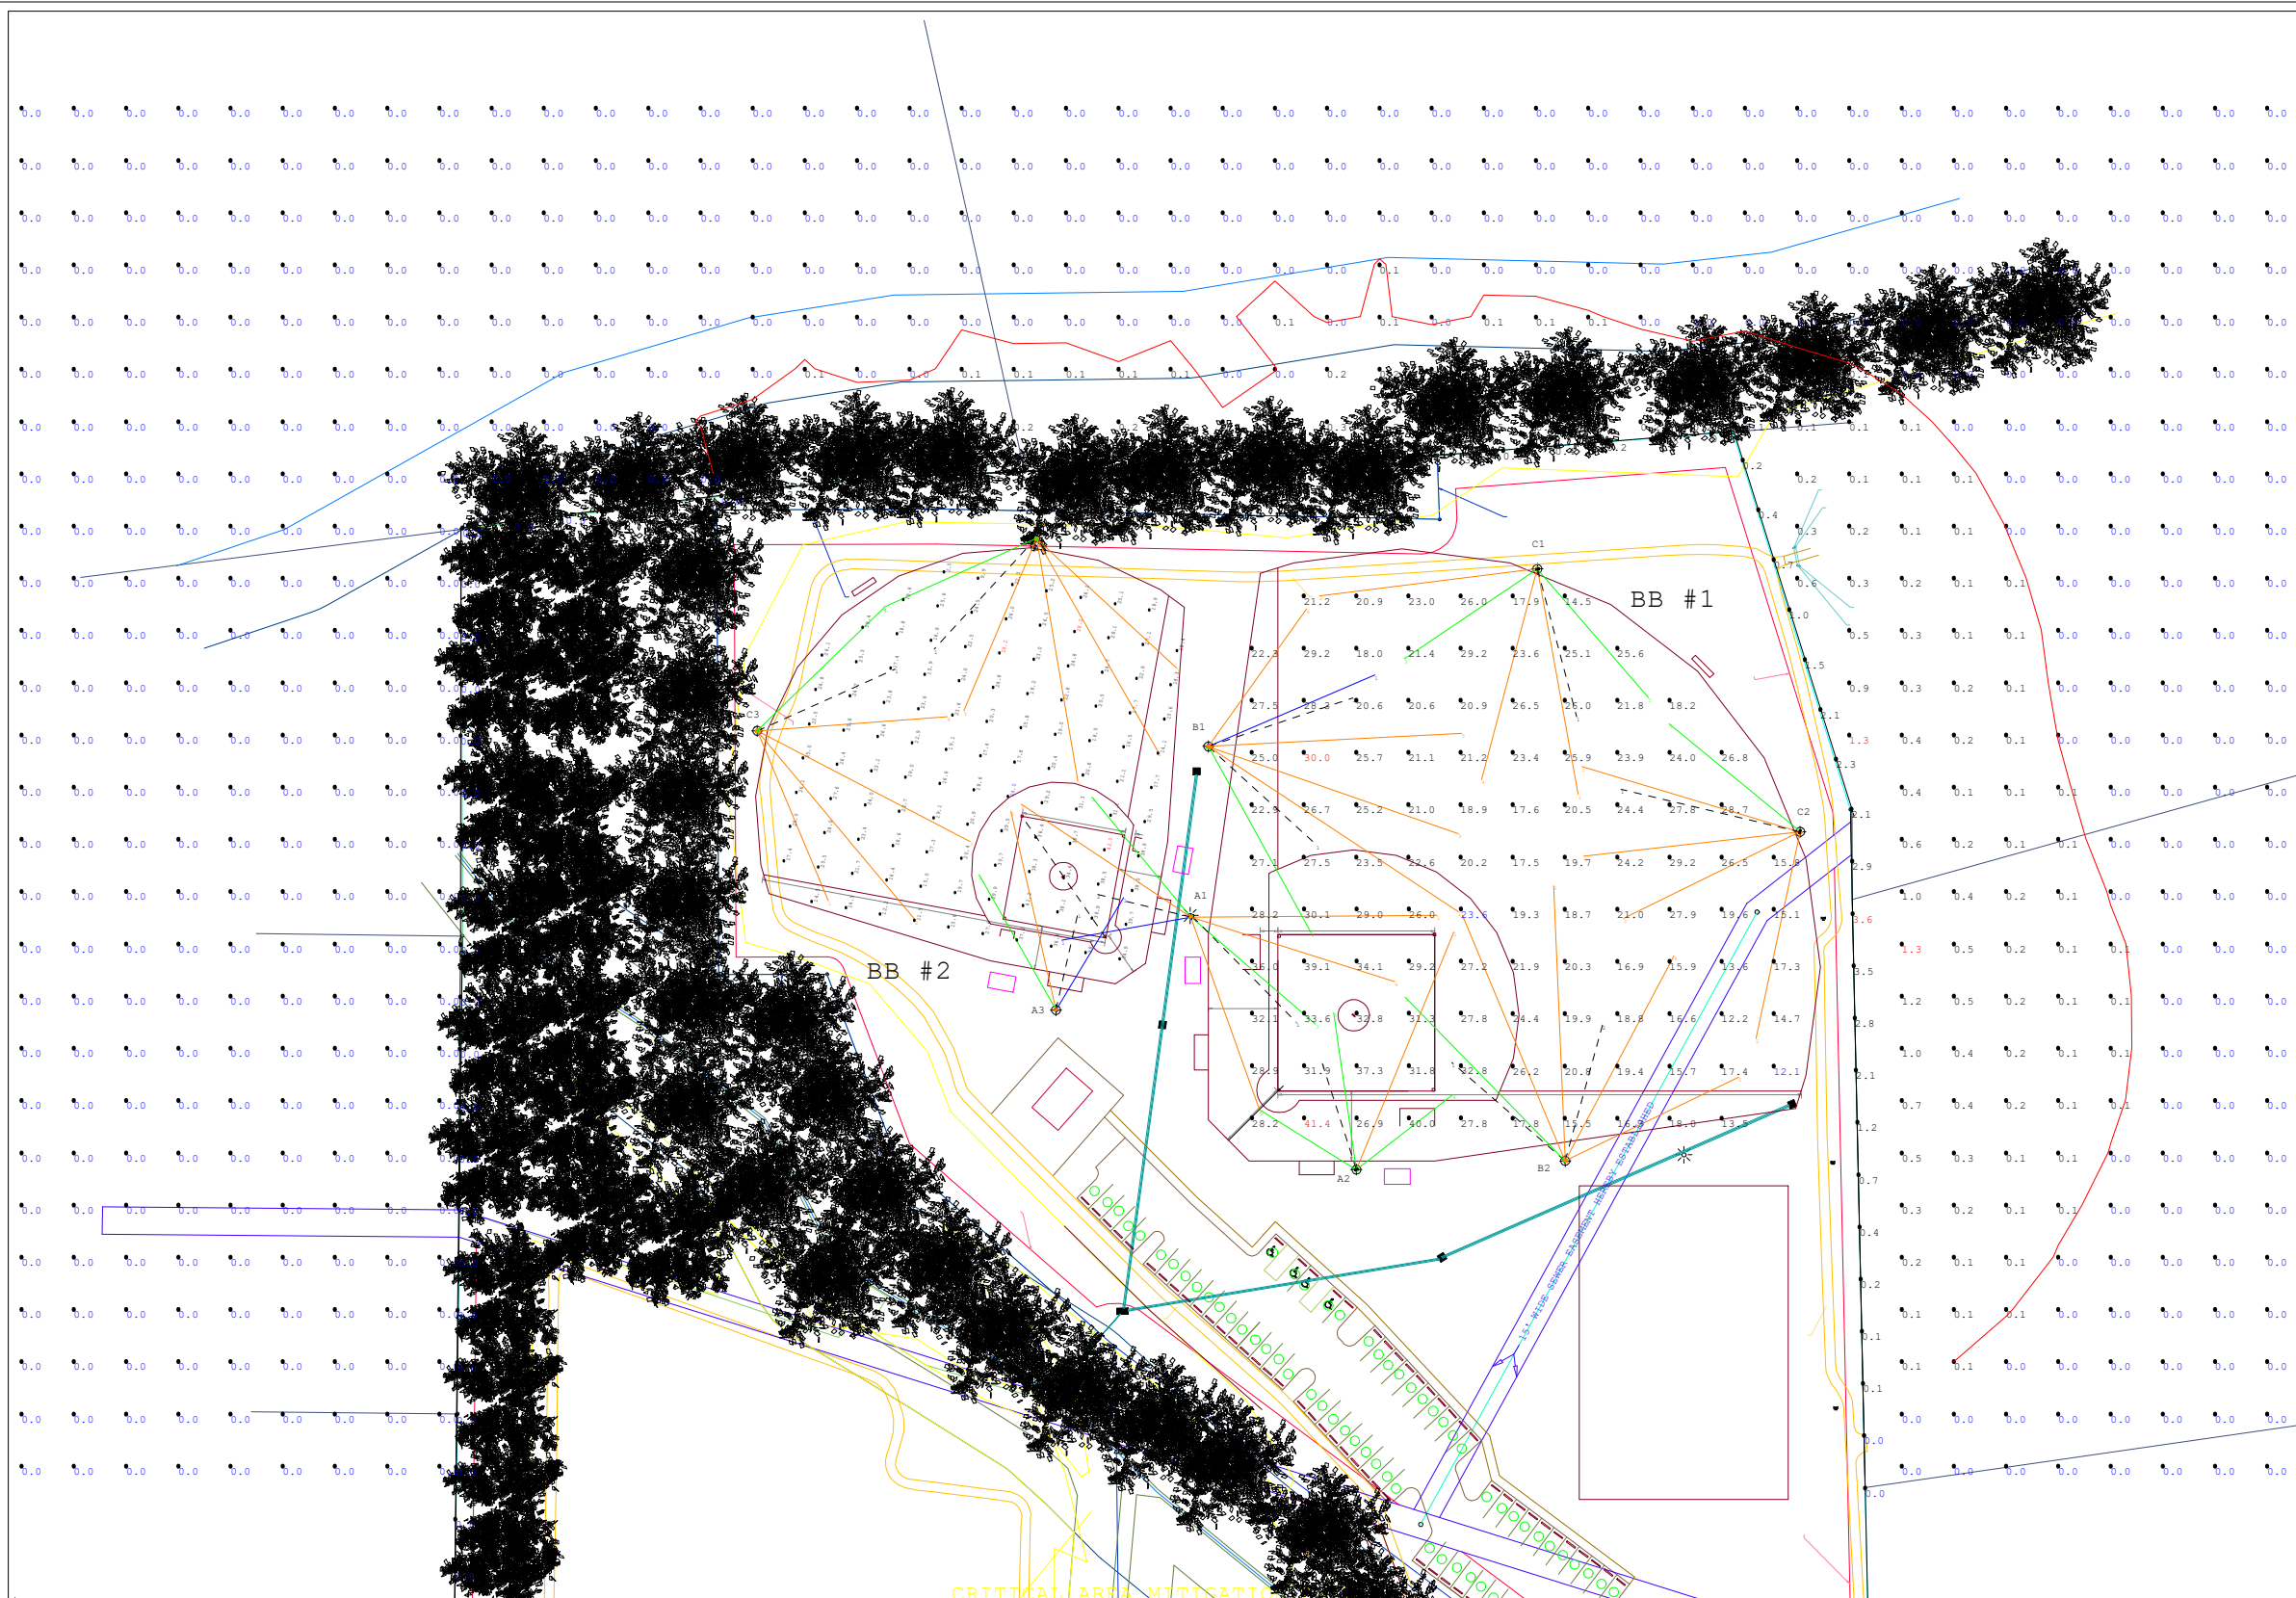

Pole Wattage Summary	
Scene: DEFAULT	
Label	Total Watts
A1	5600
A2	3200
A3	2400
B1	4800
B2	4000
C1	4000
C2	4000
C3	4000
C4	4000
TOTAL	36000

Pole Summary		
Scene: DEFAULT		
Poles	# Lums	MH
A1-BB#1	4	70'
A1-BB#2	3	70'
A1-UP	2	20'
A2	4	70'
A2-UP	1	20'
A3	3	70'
A3-UP	1	20'
B1	6	70'
B1-UP	2	20'
B2	5	70'
B2-UP	2	20'
C1	5	70'
C1-UP	1	20'
C2	5	70'
C2-UP	1	20'
C3	5	60'
C3-UP	1	20'
C4	5	60'
C4-UP	1	20'

Calculation Summary										
Scene: DEFAULT										
Label	Units	Avg	Max	Min	Max/Min	# Pts	PtSpLr	PtSpTb	CV	UG
BB #1 INFIELD	Fc	31.48	41.4	23.6	1.75	25	30	30	0.14	1.54
BB #1 OUTFIELD	Fc	21.56	30.0	12.1	2.48	83	30	30	0.21	1.75
BB #2 INFIELD	Fc	34.94	42.0	24.0	1.75	25	20	20	0.14	1.38
BB #2 OUTFIELD	Fc	20.96	28.2	2.5	11.28	88	20	20	0.22	10.24
EXTENDED SPILL	Fc	0.03	1.3	0.0	N.A.	907	30	30	N.A.	N.A.
PROPERTY LINE	Fc	0.60	3.6	0.0	N.A.	69	30	N.A.	N.A.	N.A.

Luminaire Schedule					
Scene: DEFAULT					
Symbol	Qty	Label	LLF	Lum. Watts	Arrangement
	12	TSLM-EV-NLV_UP	0.950	800	Single
	3	TSLEW-EV-NLV	0.950	800	Single
	29	TSLM-EV-NLV	0.950	800	Single
	13	TSLW-EV-NLV	0.950	800	Single

1. THIS LIGHTING DESIGN IS BASED ON INFORMATION SUPPLIED BY OTHERS. SITE DETAILS PROVIDED HEREON ARE REPRODUCED ONLY AS A REFERENCE AND FIELD CONDITIONS MAY SIGNIFICANTLY AFFECT PREDICTED PERFORMANCE. PRIOR TO INSTALLATION, CRITICAL SITE INFORMATION (POLE LOCATION, OBSTRUCTION, MOUNTING HEIGHT, ETC.) SHOULD BE COORDINATED WITH THE CONTRACTOR AND/OR SPECIFIER RESPONSIBLE FOR THE PROJECT.
 2. LUMINAIRE DATA IS TESTED TO INDUSTRY STANDARD UNDER LABORATORY CONDITIONS. OPERATING VOLTAGE AND NOMINAL MANUFACTURING TOLERANCES OF LUMINAIRE AND LUMINAIRE MAY AFFECT FIELD RESULTS.
 3. COMPLIANCE TO FACILITY CODE AND OTHER LOCAL REQUIREMENTS IS THE RESPONSIBILITY OF THE OWNER AND/OR THE OWNER'S REPRESENTATIVE.

DRAWN BY: AMP
 Date: 1/31/2025
 SCALE: NTS
 Page 1 of 1
 25-2258-BB-SB-AGI